



GENERAL NOTES:

1. ALL REFRIGERANT COPPER PIPE SHALL BE EMBED THROUGH NEW DRY WALL PARTITION. SEE MECHANICAL PLAN.
2. DRAIN OF A/C UNIT AT E.M.D MANAGER ROOM SHALL BE TAP INTO THE TOILET DRAIN. SEE MECHANICAL PLAN.
3. EXISTING (1) 1.0HP A/C UNIT AT HR STORAGE ROOM SHALL BE RELOCATED TO ASST. HR MANAGER OFFICE. SEE MECHANICAL PLAN.
4. EXISTING (1) 3.0HP FCU AT VP A.O.M.G OFFICE SHALL BE RELOCATED TO VIP LOUNGE. SEE MECHANICAL PLAN.
5. EXISTING (2) 1.5HP FCU AT VIP LOUNGE SHALL BE RELOCATED TO VP A.O.M.G OFFICE AND A.O.M.G OFFICE. SEE MECHANICAL PLAN.
6. EXISTING (2) 1.0HP FCU AT M.I.S DEPARTMENT OFFICE SHALL BE RELOCATED AT RIGHT WALL OF M.I.S OFFICE. SEE MECHANICAL PLAN.
7. (2) EXISTING ACCU AFFECTED BY CANOPY WIDENING SHALL BE RELOCATED ON THE EXISTING 6" THK CONCRETE PAD OF FILE ROOM. SEE MECHANICAL PLAN.
8. NEW ACCU AT VIP LOUNGE SHALL BE LOCATE ON EXISTING 6" THK. CONCRETE PAD. SEE MECHANICAL PLAN.
9. ALL EXISTING ACCU AFFECTED BY PROPOSED NEW WALL CLADDING SHALL BE RELOCATED ON THE ROOF TOP OF COB.
10. ALL NEWLY INSTALLED A/C UNIT SHALL BE CONNECTED AND PROGRAMMED AT THE BMS.

LEGEND:

- ACCU AIR COOLED CONDENSER UNIT
- FCU FAN COIL UNIT
- E EXISTING
- N NEW
- NP NEW POSITION / LOCATION
- HP HORSEPOWER
- EXISTING ACCU
- EXISTING CEILING MOUNTED FCU
- EXISTING WALL MOUNTED FCU
- EXISTING FLOOR MOUNTED FCU
- EXISTING CEILING CASSETTE FCU
- NEW PROPOSED LOCATION OF ACCU
- NEW PROPOSED LOCATION OF CEILING MOUNTED FCU
- NEW PROPOSED LOCATION OF WALL MOUNTED FCU
- NEW PROPOSED LOCATION OF FLOOR MOUNTED FCU
- NEW ACCU
- NEW CEILING MOUNTED FCU
- NEW WALL MOUNTED FCU
- NEW FLOOR MOUNTED FCU

1 CORPORATE BUILDING ROOFTOP MECHANICAL PLAN  
A-2 SCALE 1:250 MTS.

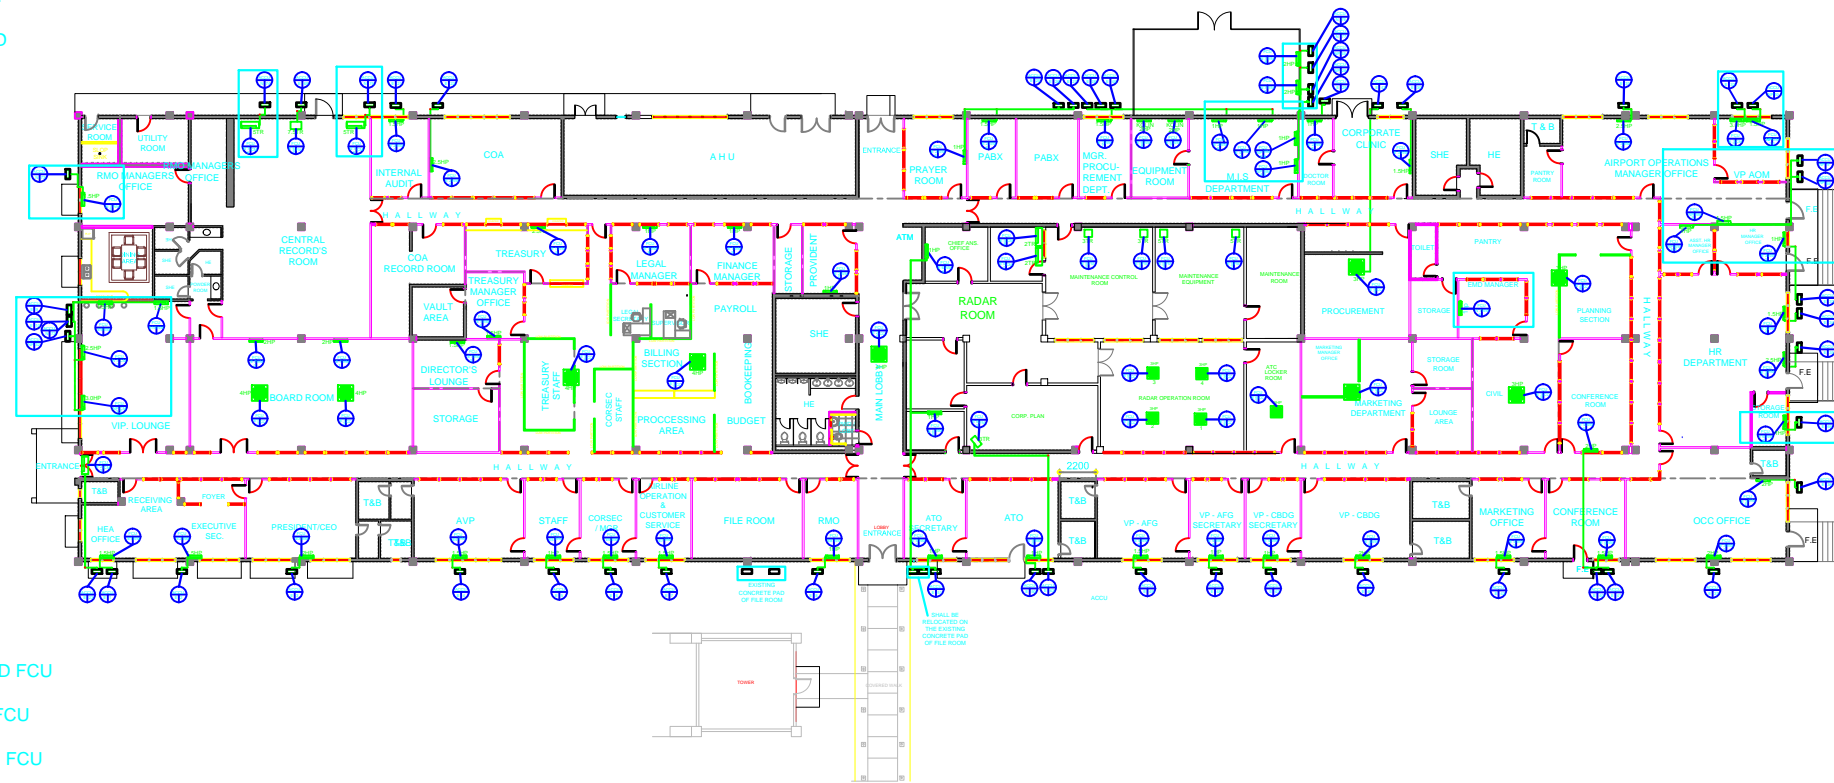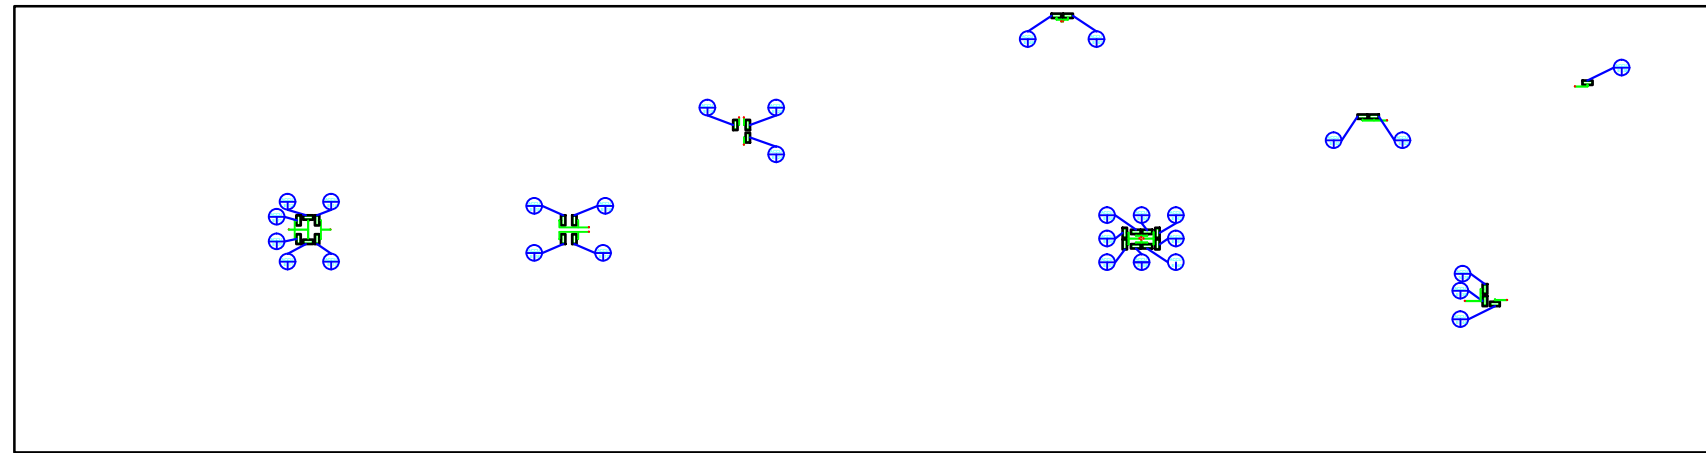

1 CORPORATE BUILDING MECHANICAL FLOOR PLAN  
A-2 SCALE 1:250 MTS.

NOTE:  
1. VERIFY PLAN OR COORDINATE WITH THE ASSIGNED ENGINEER OR ARCHITECT ON SITE THE EXTENT OF THE WORKS.  
2. FINISH AND QUALITY OF MATERIALS IS SUBJECT FOR APPROVAL OF THE DESIGNING ARCHITECT OR ENGINEER



PROJECT / LOCATION:	DESIGN STAFF:	RECOMMENDING APPROVAL:	APPROVED BY:	REMARKS/REVISED:	DISCIPLINE:	SHEET NO.:
IMPROVEMENT OF CORPORATE BUILDING CIVIL AVIATION COMPLEX, CLARK FREEPORT ZONE, PAMPANGA	GBLN II	FEDERICO G. GARCIA Jr. OIC - EMD	DAN A. BAUTISTA VP-OPERATION MANAGEMENT GROUP		MECHANICAL CORPORATE BUILDING MECHANICAL FLOOR PLAN CORPORATE BUILDING ROOFTOP MECHANICAL PLAN	M-1 02