

- LEGEND:**
- FCU** FAN COIL UNIT
 - ACCU** AIR COOLED CONDENSER UNIT
 - WACU** WINDOW AIRCONDITIONING UNIT
 - FM** FLOOR MOUNTED
 - HP** HORSEPOWER
 - A** AMPERE
 - V** VOLT
 - TR** TONNER
 - PH** PHASE
 - Hz** HERTZ
 - FLOOR MOUNTED FAN COIL UNIT LOCATION
 - AIR COOLED CONDENSER UNIT LOCATION
 - PROVISION INDOOR UNIT
 - PROVISION OUTDOOR UNIT
 - NEW WINDOW TYPE A/C UNIT

ASD BUILDING INVERTER WINDOW A/C UNIT SCHEDULE						
FAN COIL/AIR-COOLED CONDENSING UNIT SCHEDULE						
MARK	DESCRIPTION	LOCATION	NOMINAL COOLING (HP)	REFRIGERANT	ELECTRICAL V-PH-HZ	REMARKS
WACU-ASD-1	WINDOW TYPE, STRAIGHT COOL	SECURITY LOUNGE	2.0	R-410A	220-1-60	SEE NOTES
WACU-ASD-2	WINDOW TYPE, STRAIGHT COOL	SECURITY LOUNGE	2.0	R-410A	220-1-60	SEE NOTES


NOTES:

- INSTALLATION OF A/C EQUIPMENTS SHALL BE DONE IN ACCORDANCE WITH THE MANUFACTURER'S STANDARDS.
- PROVIDE CONDENSING UNIT WITH MANUFACTURER'S COATED COILS, THERMAL OVERLOAD PROTECTION AND OVER VOLTAGE PROTECTION.
- PROVIDE HAND HELD REMOTE CONTROL OPTION.
- PROVIDE FRAME SUPPORT FOR WACU.
- ALL DIMENSIONS ARE IN MILLIMETER UNLESS OTHERWISE SPECIFIED.
- ALL TOILET DOORS SHALL BE PROVIDED WITH LOUVERS
- WORKMANSHIP: THE WORK THROUGHOUT WAS EXECUTED IN THE BEST & MOST THOROUGH MANNER KNOWN TO TRADE AND TO THE SATISFACTION OF ARCHITECT AND THE ENGINEER.

PROVISION FOR ADDITIONAL INVERTER SPLIT A/C UNIT SCHEDULE						
FAN COIL/AIR-COOLED CONDENSING UNIT SCHEDULE						
MARK	DESCRIPTION	LOCATION	NOMINAL COOLING (TR)	REFRIGERANT	ELECTRICAL V-PH-HZ	REMARKS
FCU-ASD-1/ACCU-ASD-1	FLOOR MOUNTED TYPE, STRAIGHT COOL	SECURITY LOUNGE	3.0	R-410A	220-1-60 30 A	SEE NOTES
FCU-ASD-2/ACCU-ASD-2	FLOOR MOUNTED TYPE, STRAIGHT COOL	SECURITY LOUNGE	3.0	R-410A	220-1-60 30 A	SEE NOTES
FCU-ASD-3/ACCU-ASD-3	FLOOR MOUNTED TYPE, STRAIGHT COOL	SECURITY LOUNGE	3.0	R-410A	220-1-60 30 A	SEE NOTES
FCU-ASD-4/ACCU-ASD-4	FLOOR MOUNTED TYPE, STRAIGHT COOL	SECURITY LOUNGE	3.0	R-410A	220-1-60 30 A	SEE NOTES
FCU-ASD-5/ACCU-ASD-5	FLOOR MOUNTED TYPE, STRAIGHT COOL	SECURITY LOUNGE	3.0	R-410A	220-1-60 30 A	SEE NOTES
FCU-ASD-6/ACCU-ASD-6	FLOOR MOUNTED TYPE, STRAIGHT COOL	SECURITY LOUNGE	3.0	R-410A	220-1-60 30 A	SEE NOTES

NOTES:

- INSTALLATION OF A/C EQUIPMENTS SHALL BE DONE IN ACCORDANCE WITH THE MANUFACTURER'S STANDARDS.
- PROVIDE CONDENSING UNIT WITH MANUFACTURER'S COATED COILS, THERMAL OVERLOAD PROTECTION, TIME DELAY AND OVER VOLTAGE PROTECTION.
- FAN COIL UNIT WITH HAND HELD REMOTE CONTROL OPTION.
- LOCATE CONDENSING UNIT ON 6" THK. CONCRETE PAD.
- ALL DIMENSIONS ARE IN MILLIMETER UNLESS OTHERWISE SPECIFIED.
- REFRIGERANT COPPER TUBE SHALL BE EMBED.
- REFRIGERANT COPPER TUBE SHALL BE CLAD.
- ALL FLOOR MOUNTED EQUIPMENT SHALL BE PROVIDED WITH VIBRATION ISOLATORS
- ALL TOILET DOORS SHALL BE PROVIDED WITH LOUVERS
- PIPE: ALL EQUIPMENT DRAIN DRAINS SHALL BE TAP TO THE NEAREST FLOOR DRAIN PROVIDED BY PLUMBING CONTRACTOR.
- WORKMANSHIP: THE WORK THROUGHOUT WAS EXECUTED IN THE BEST & MOST THOROUGH MANNER KNOWN TO TRADE AND TO THE SATISFACTION OF ARCHITECT AND THE ENGINEER.

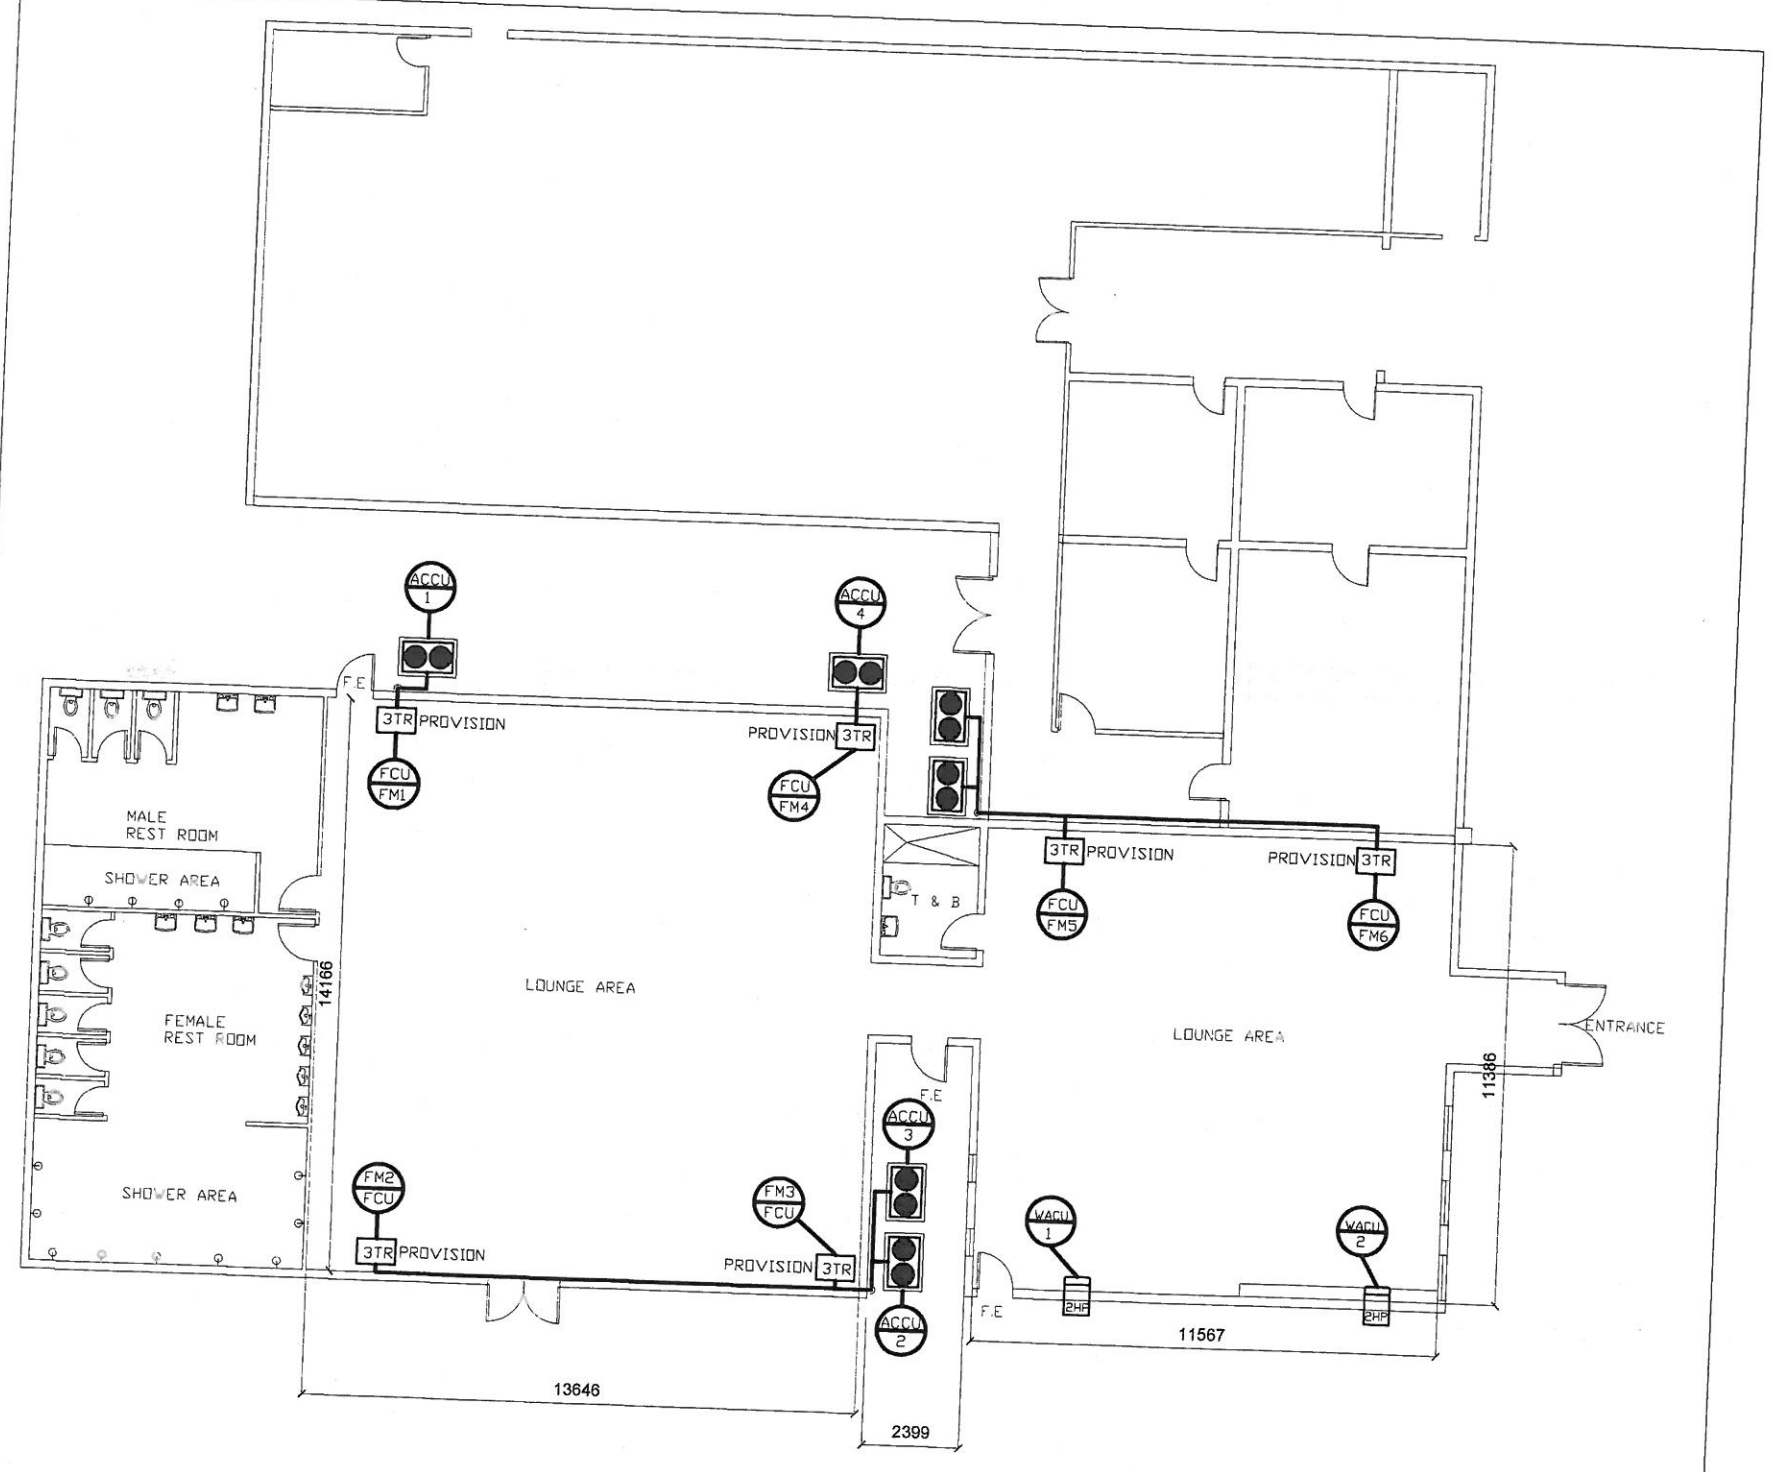

SECURITY LOUNGE PROPOSED MECHANICAL FLOOR PLAN
 SCALE: 1:100 MTS

	PROJECT / LOCATION:	DESIGN STAFF:	RECOMMENDING APPROVAL:	APPROVED BY:	REMARKS/REVISED:	DISCIPLINE:	SHEET NO.:
	IMPROVEMENT OF SECURITY LOUNGE AT BLDG. 7535 ASD BUILDING, CIVIL AVIATION COMPLEX, CLARK FREEPORT ZONE, PAMPANGA	GBLN II	FEDERICO G. GARCIA Jr. OIC - EMD	DAN A. BAUTISTA VP-OPERATION MANAGEMENT GROUP		MECHANICAL	ASD BUILDING INVERTER SPLIT A/C UNIT SCHEDULE SECURITY LOUNGE PROPOSED MECHANICAL FLOOR PLAN